


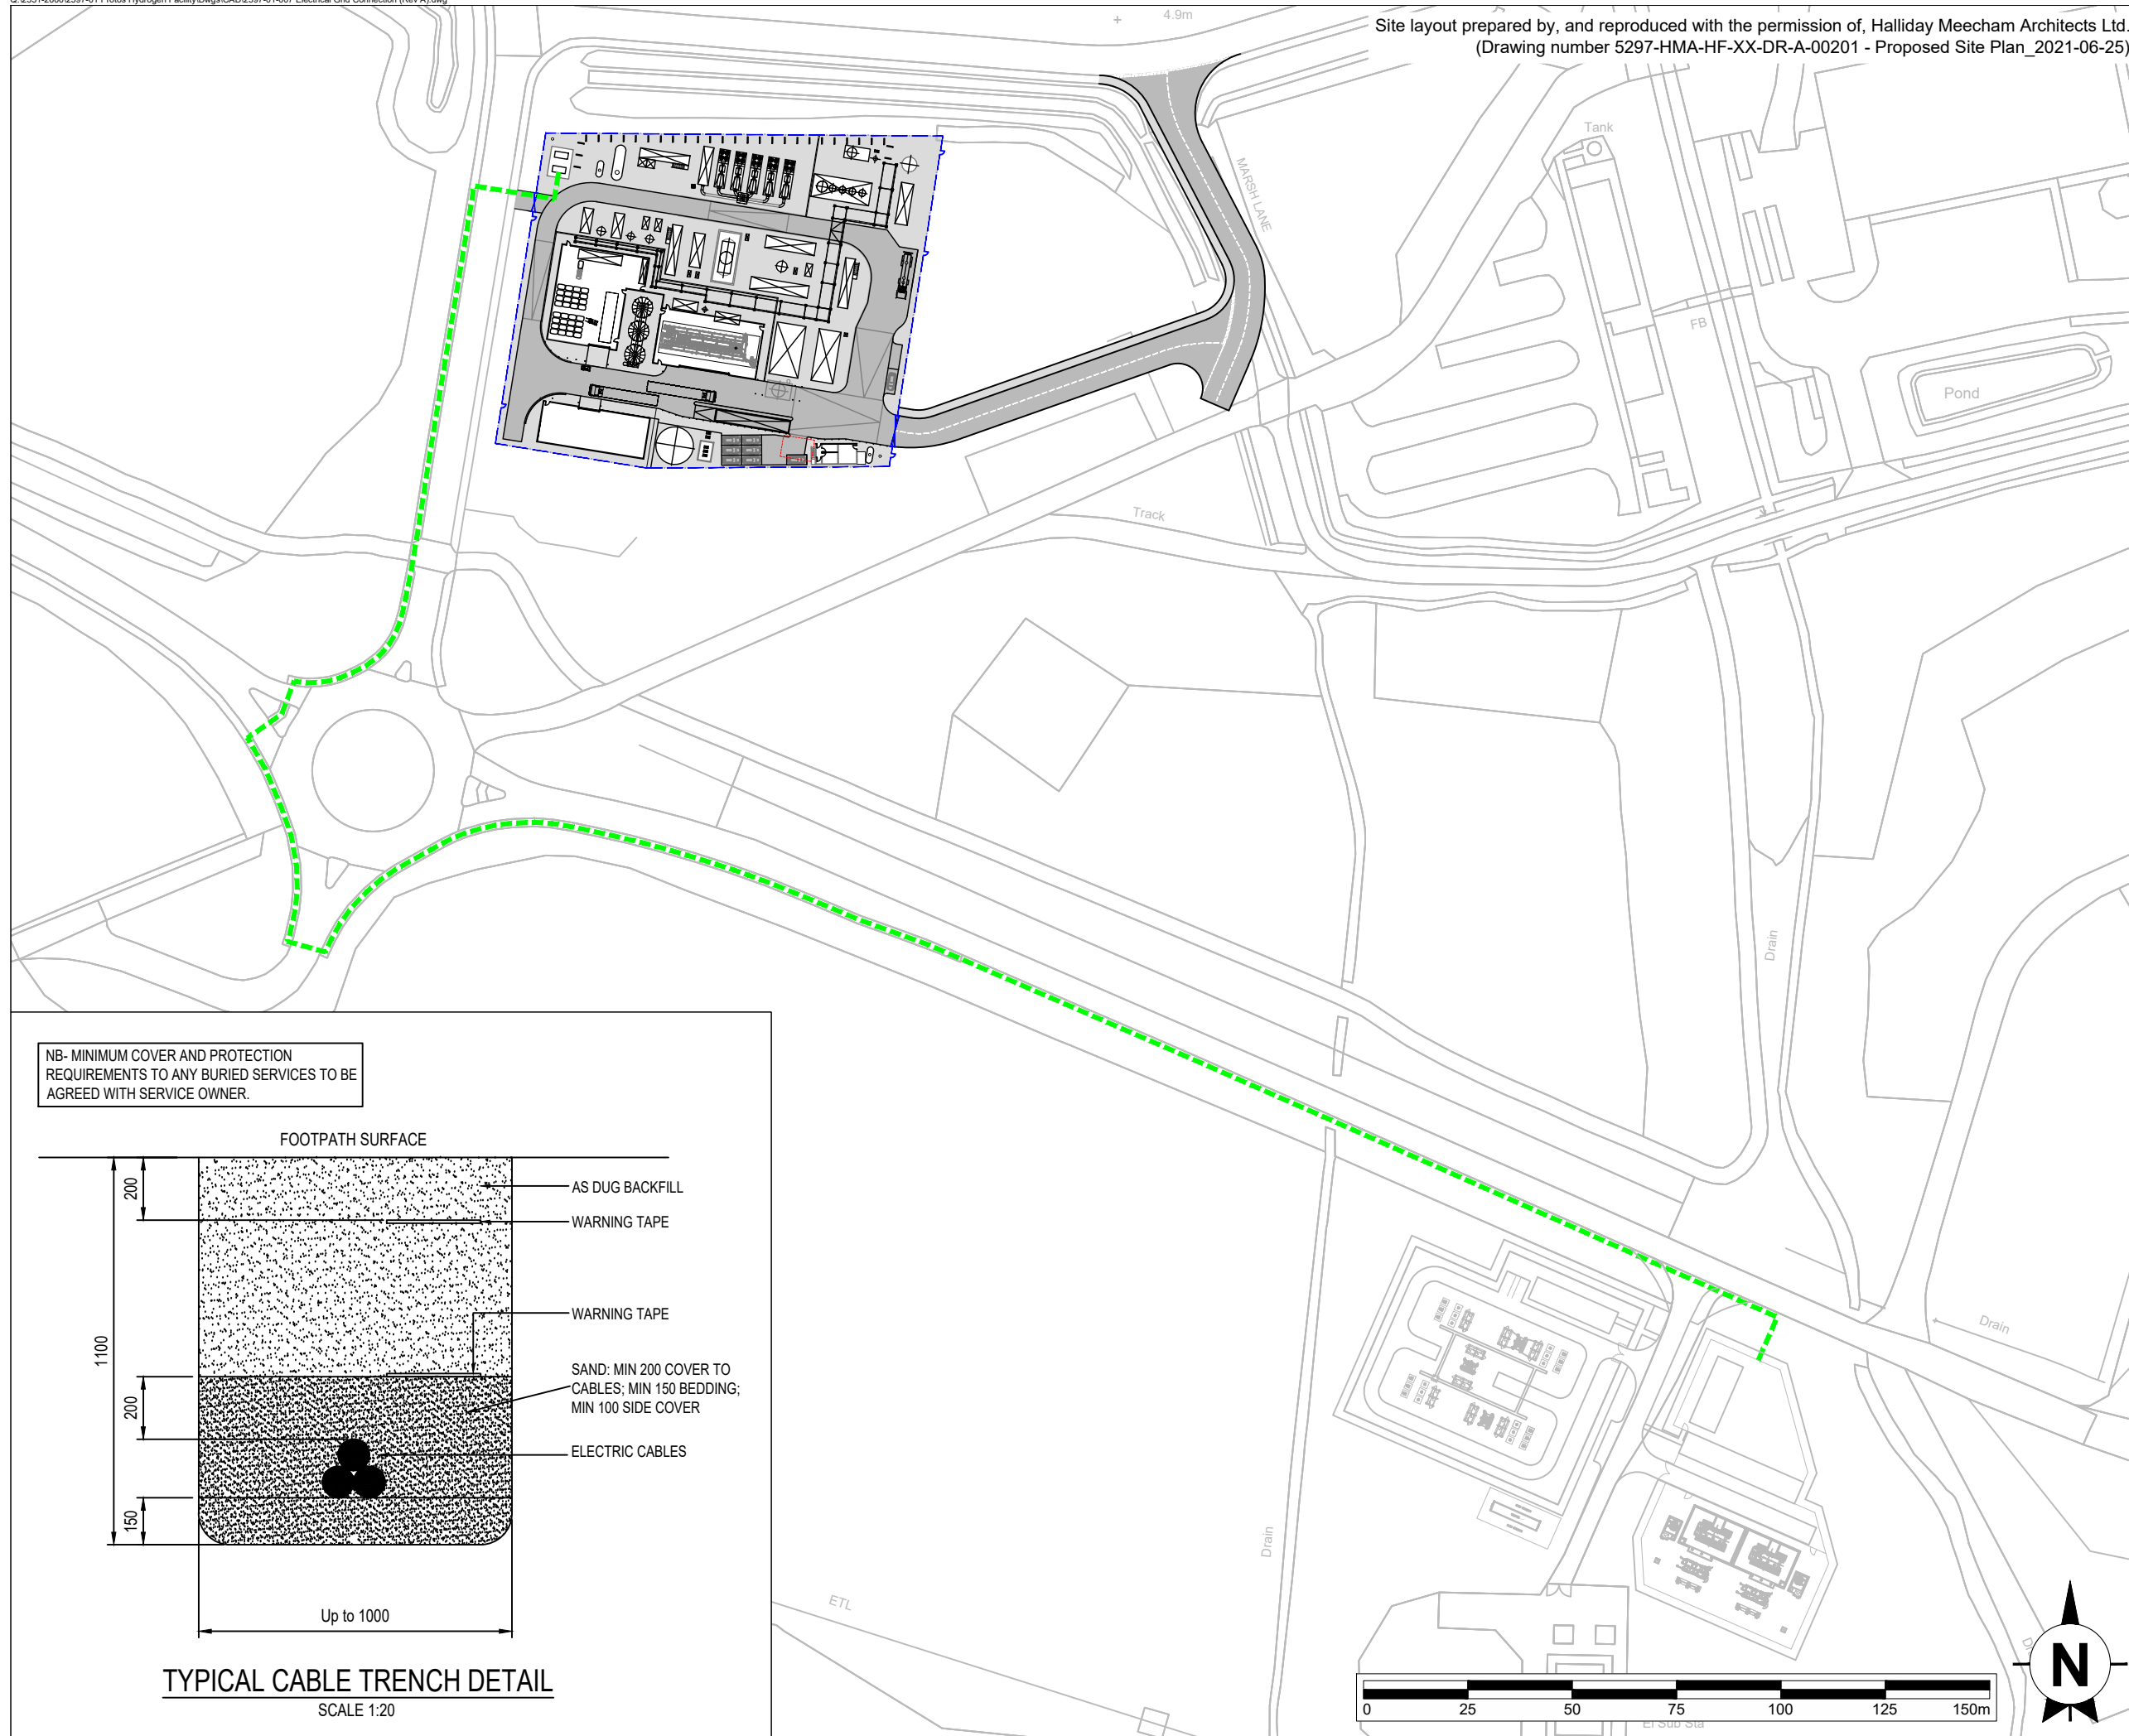
Site layout prepared by, and reproduced with the permission of, Halliday Meecham Architects Ltd.
 (Drawing number 5297-HMA-HF-XX-DR-A-00201 - Proposed Site Plan_2021-06-25)

This drawing is the copyright of AXIS P.E.D Limited and may not be loaned, copied or reproduced in any way -or used for any offer, quote, tender or construction purposes without written consent of the company to do so


Follow any figured dimensions - do not scale for construction purposes. IF IN DOUBT ASK.

Revision History	Date
A Updated site layout	25-06-21

 Grid Connection Route



NB- MINIMUM COVER AND PROTECTION REQUIREMENTS TO ANY BURIED SERVICES TO BE AGREED WITH SERVICE OWNER.

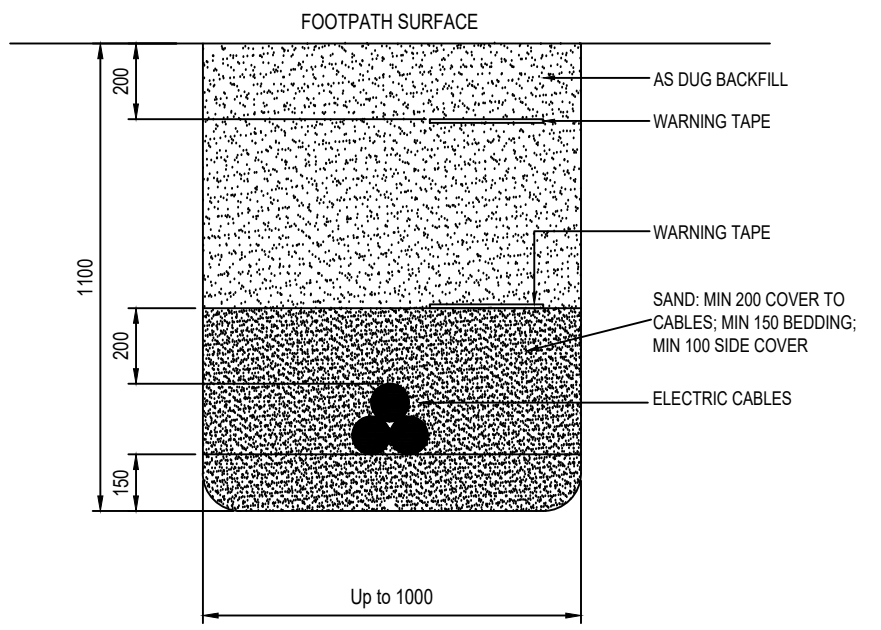

TYPICAL CABLE TRENCH DETAIL
SCALE 1:20



axis
 0844 8700 007 - www.axisped.co.uk

client: PEEL ENVIRONMENTAL & WASTE2TRICITY
 project: PROTOS HYDROGEN FACILITY
 drawing title: ELECTRICAL GRID CONNECTION

date: October 2019	drawn by: SM	checked: AR
drawing number: 2597-01-007	status: --	
scale(s): 1:1500@A3	rev: A	

planning environment design